

ISSUE DATES:
FEB. 18, 2010
FOR CONSTRUCTION


SHEET
OF 11 SHEETS
A9

SCALE: VARIES
JOB NO.: 21090005

SPACE
PLANNING & INTERIOR DESIGN
COMMERCIAL SPACE
SPECIALISTS
FOR KELLIS GIFT SHOP SUPPLIERS
CARROLLTON, TEXAS
Telephone: 972/414-9391
Fax: 972/414-0997

A 54,460 SF REMODEL FOR
FOR KELLIS GIFT SHOP SUPPLIERS
CARROLLTON, TEXAS

CONSTRUCTION BY:

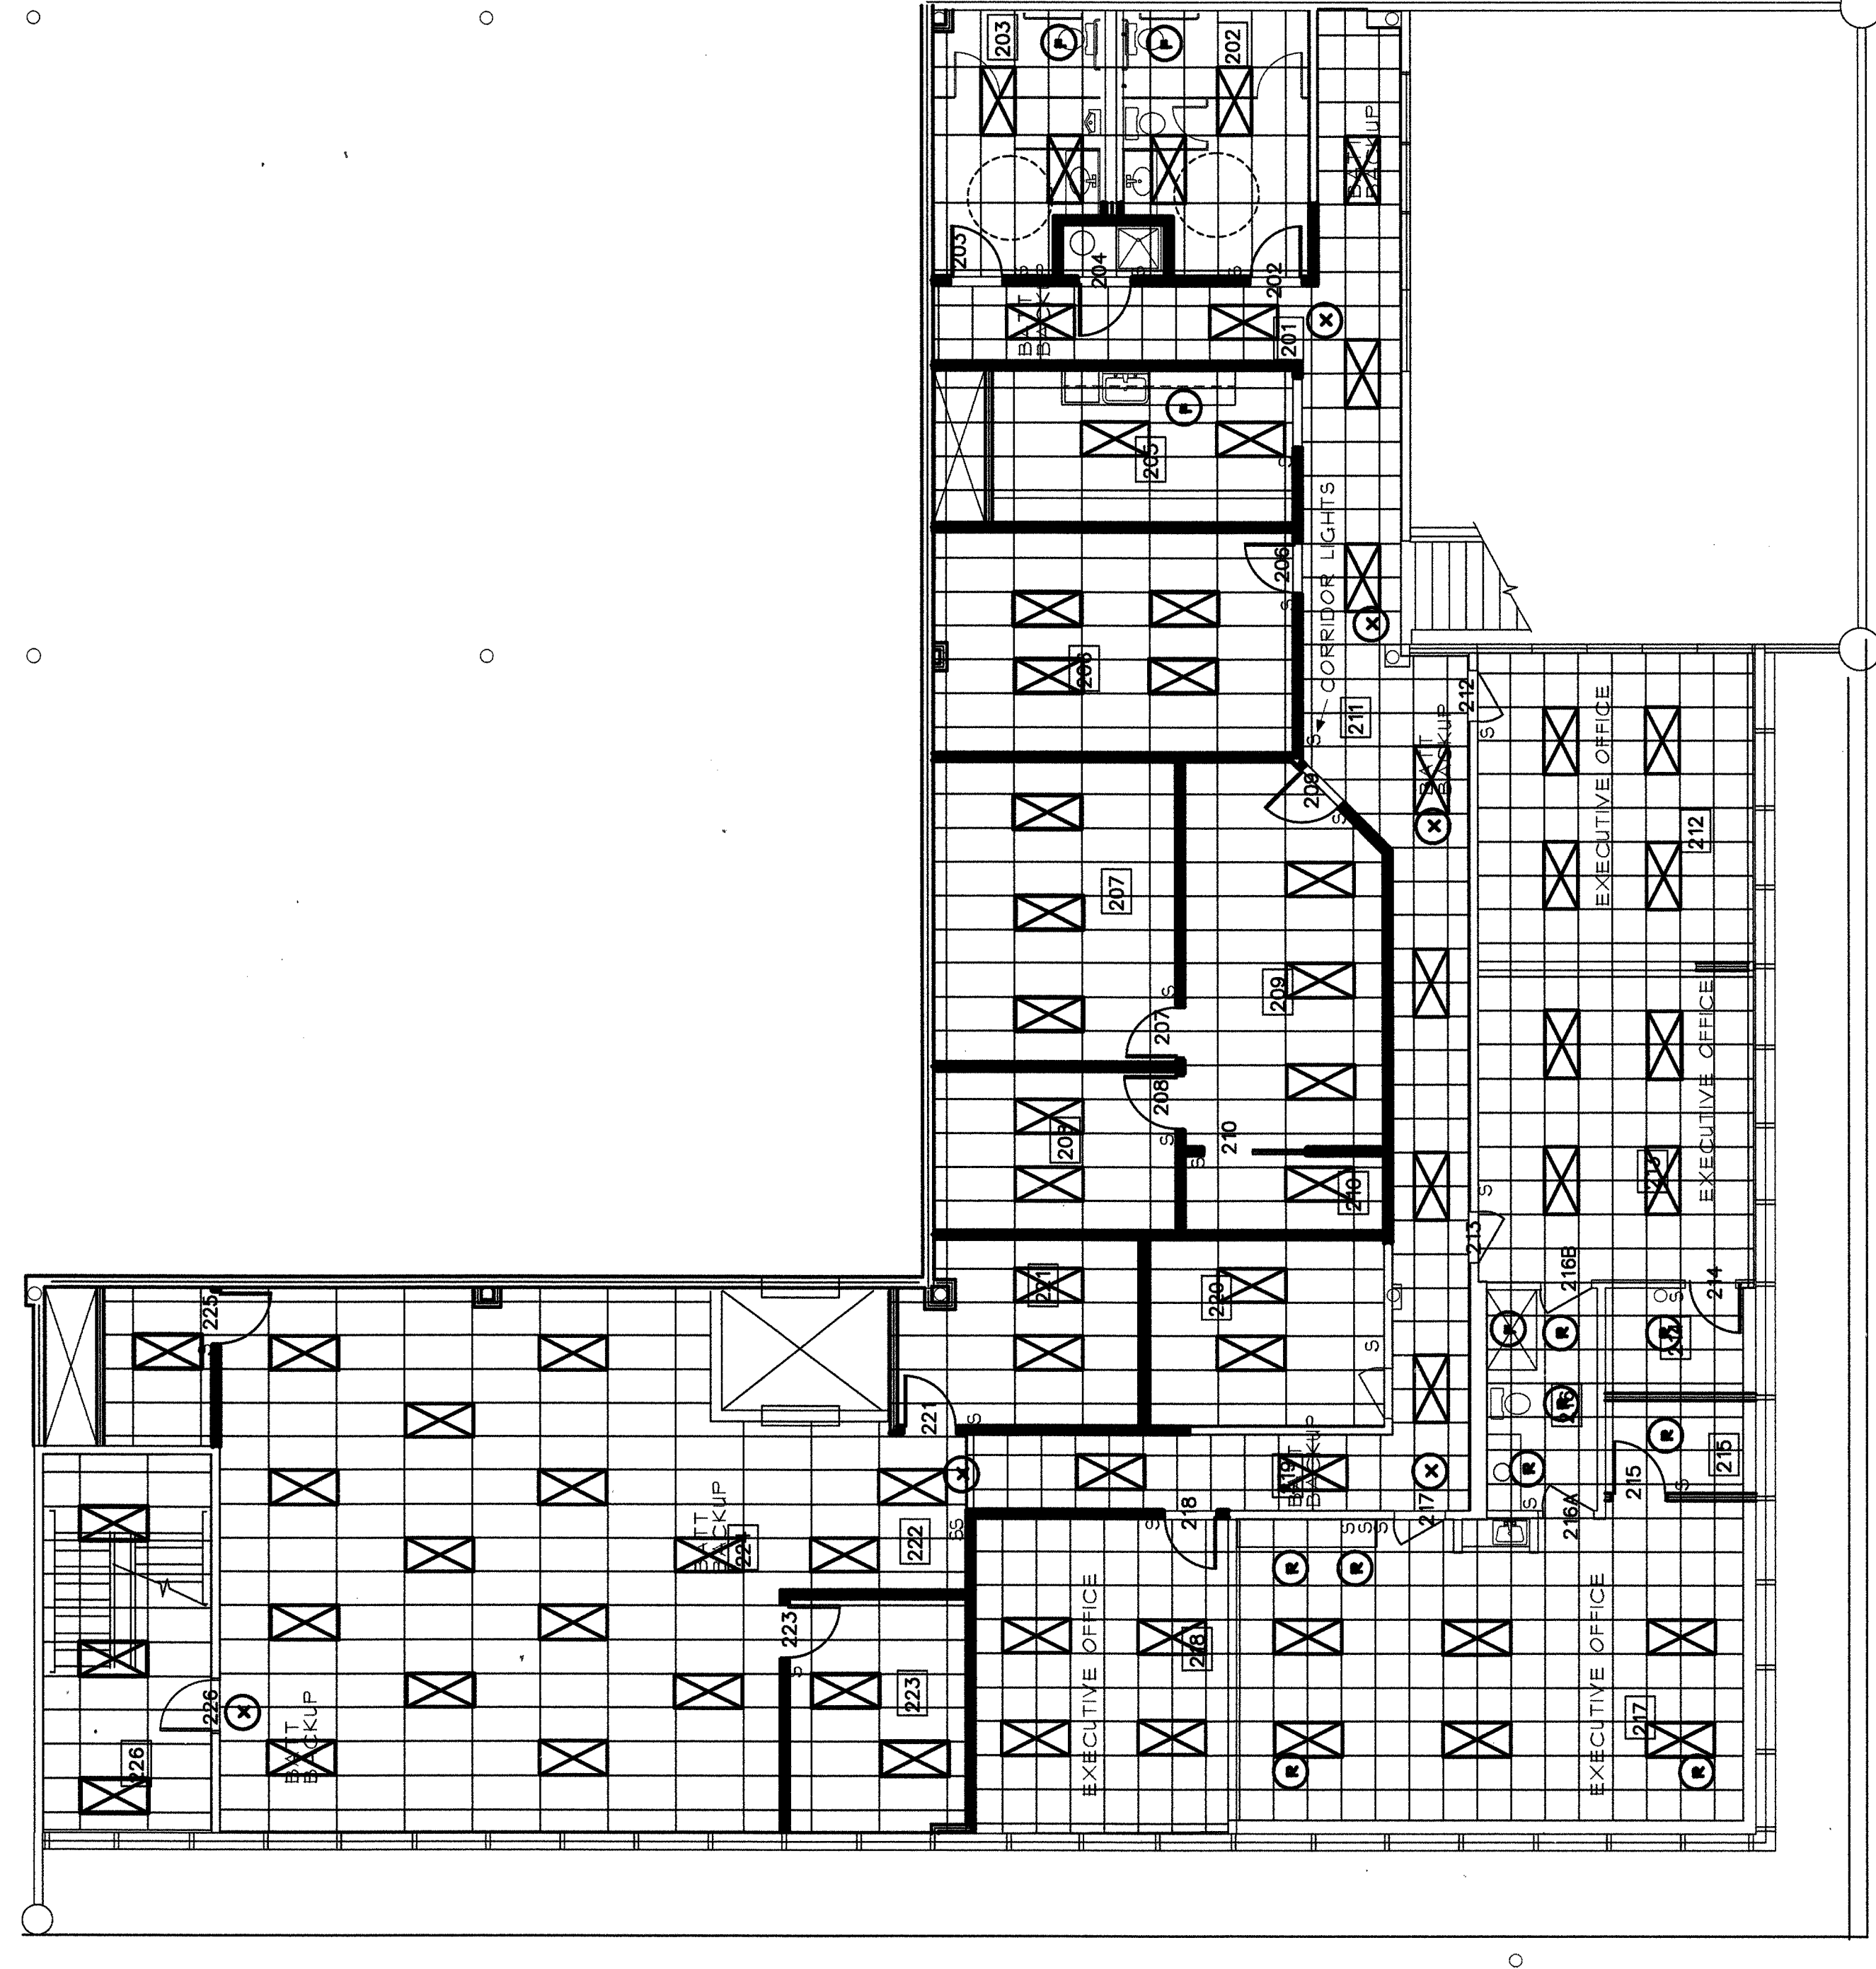


2ND FLOOR REFLECTED CEILING PLAN

SCALE 1/8" = 1'-0"

LIGHTING LEGEND

- ☒ ALL 2'x4' LIGHTS TO BE PARABOLIC LIGHTOLIER DEEPCEL PLUS DFL 208L'S 3 3/4 UNV
- ☒ ALL 2'x4' LIGHTS TO BE PARABOLIC LIGHTOLIER DEEPCEL PLUS DFL 208L'S 3 3/4 UNV WITH BATTERY BACKUP
- ⊙ EXHAUST FAN
- ⊙ EXIT LIGHT - AS REQUIRED BY CODE LOCATED TO BE PARABOLIC LIGHTOLIER DEEPCEL PLUS DFL 208L'S 3 3/4 UNV WITH BATTERY BACKUP
- ⊙ MOTION SENSOR SWITCH IN ALL AREAS EXCEPT AREAS WITH MULTIPLE SWITCHING
- ⊙ ALL FACE PLATES TO MATCH EXISTING
- ⊙ ALL ROOMS TO RECEIVE 2'x4' ARMSTRONG LAY IN SECOND LOOK WITH REVEAL IN WHITE WITH A WHITE CEILING GRID. FINE FIGURED #111
- ⊙ CORRIDORS ONLY TO RECEIVE 2'x2' ARMSTRONG LAY IN FINE FIGURED #1820 WITH A WHITE CEILING GRID
- ⊙ FOR EXECUTIVE OFFICES, TWO COVERS AND ONE RESTRICOM TO RECEIVE 1820 COVER. TWO 2'x2' ACoustICAL TILES WITH REGULAR EDGE

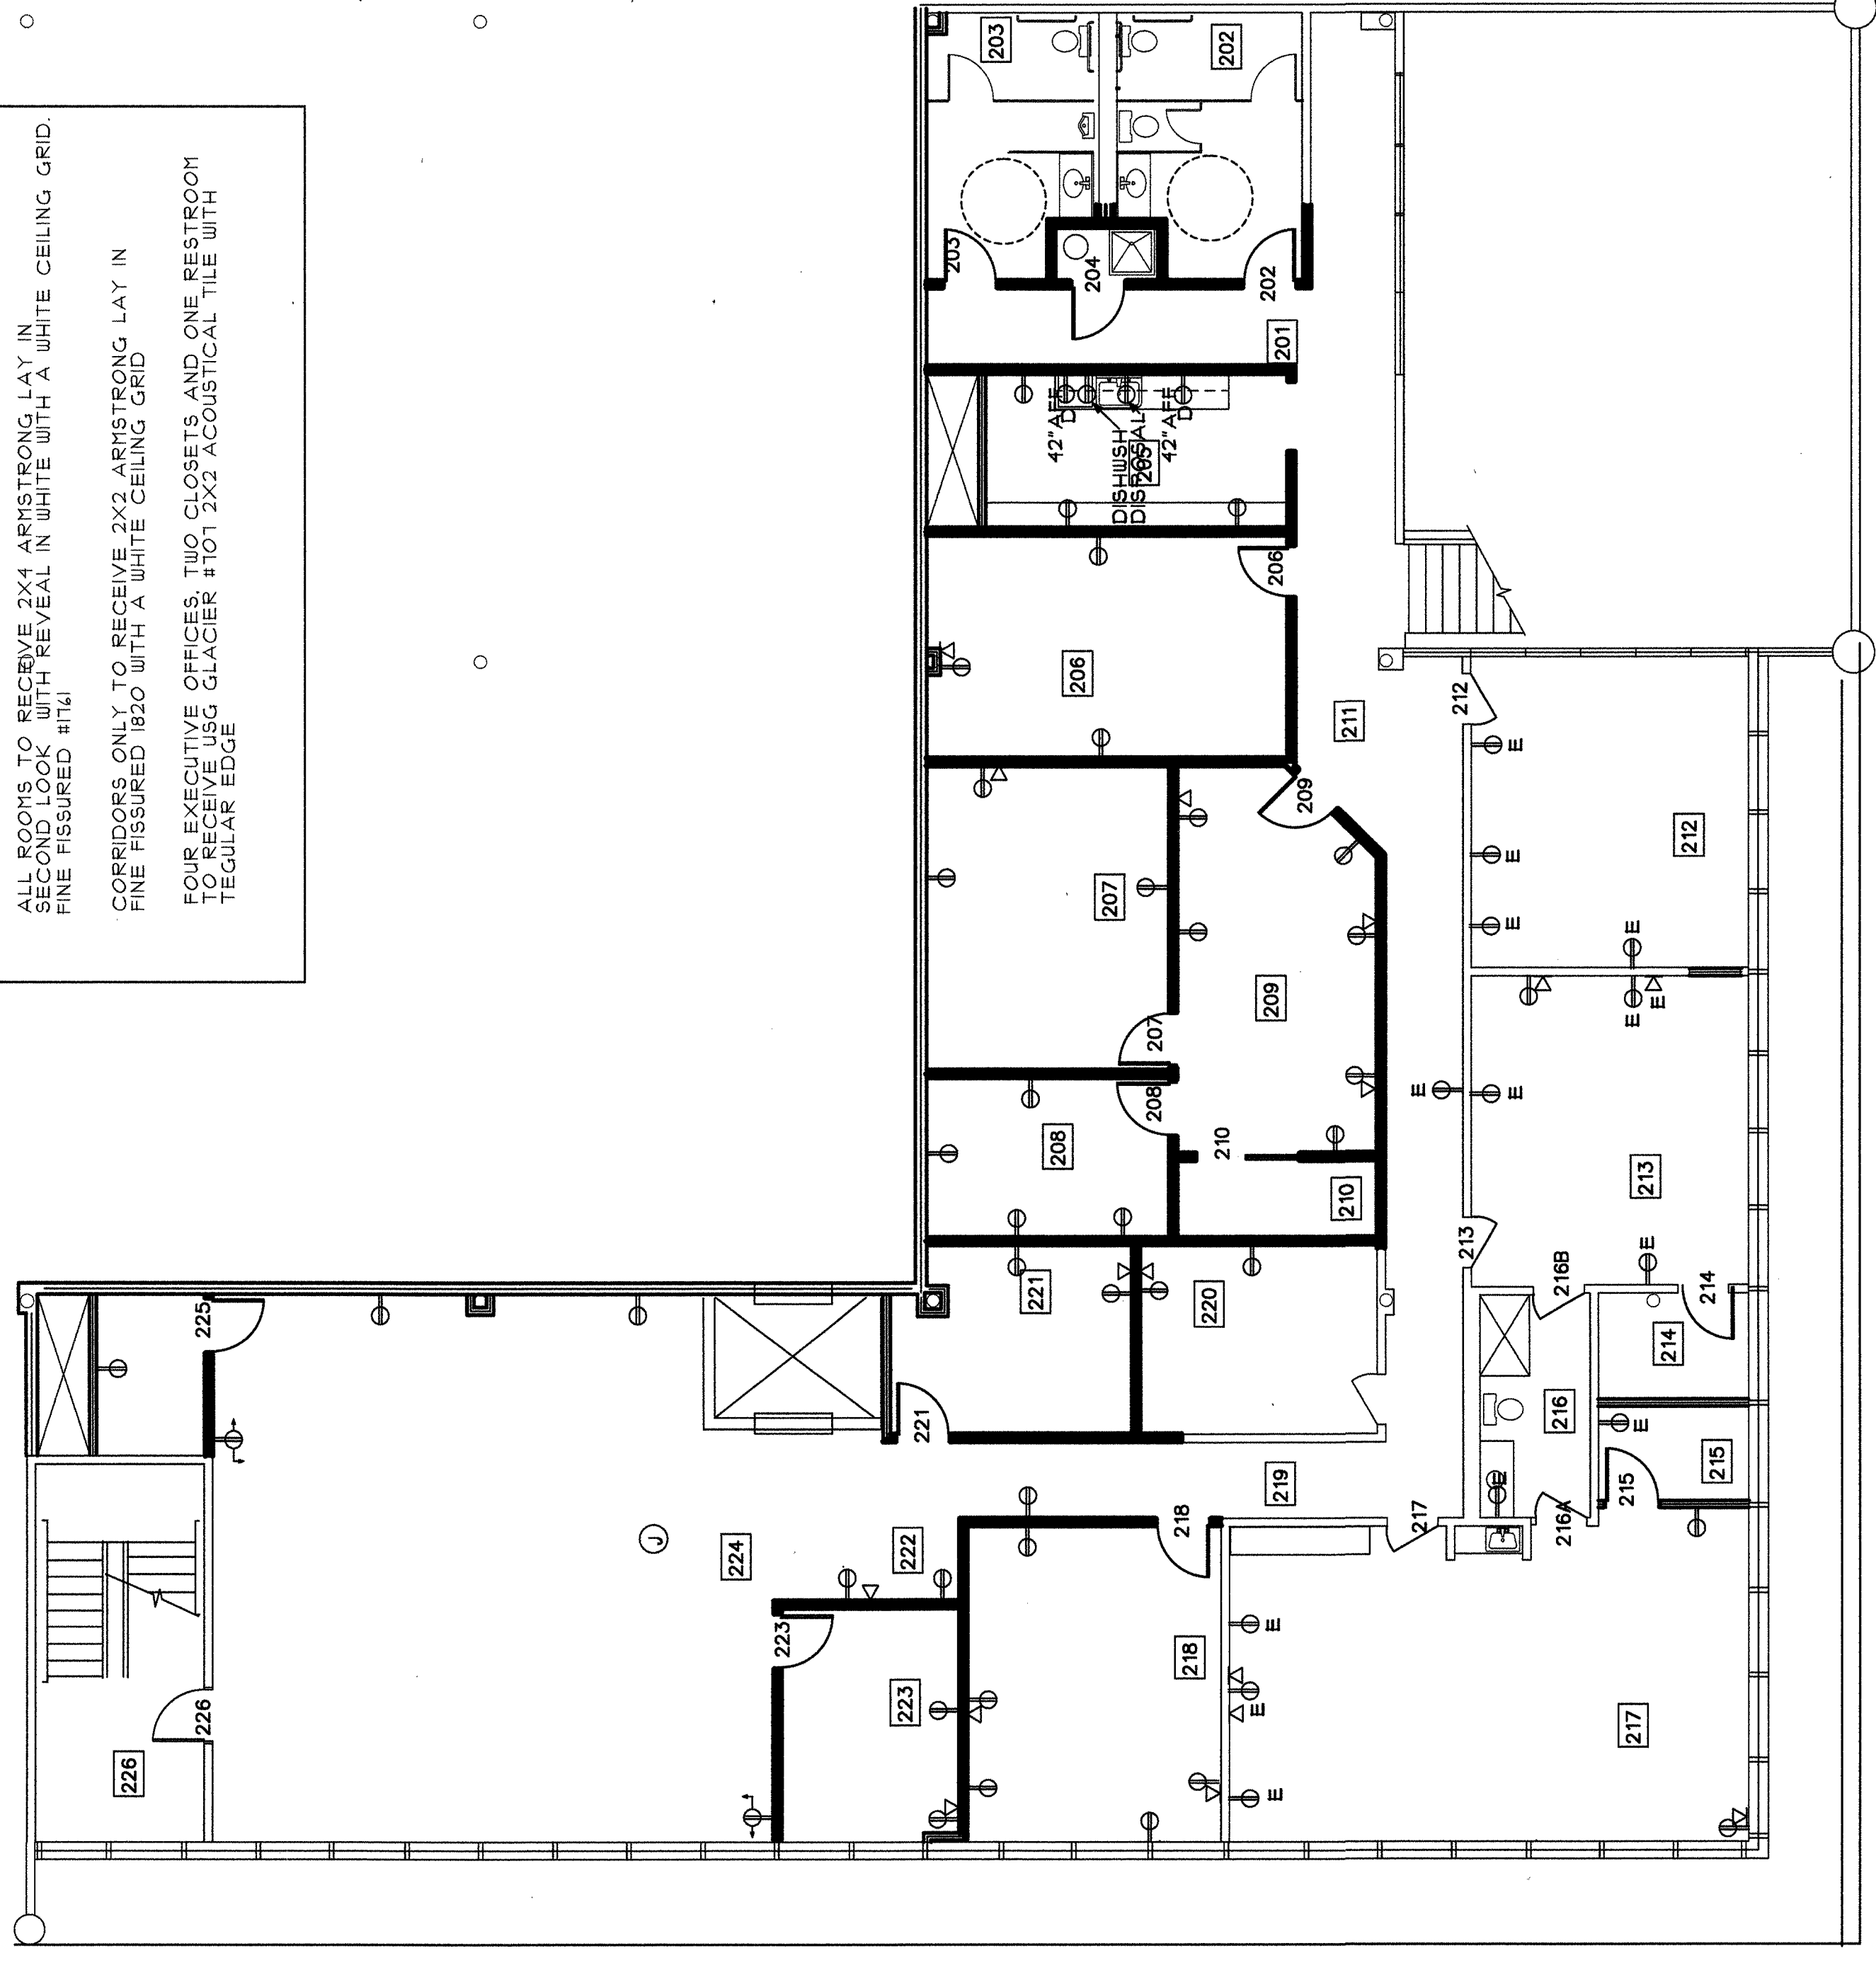

2ND FLOOR ELECTRICAL PLAN

SCALE 1/8" = 1'-0"

ELECTRICAL LEGEND

- ⊙-E EXISTING 110V DUPLEX OUTLET
- ⊙-E EXISTING TELE / DATA ROUGH-IN
- ⊙-E NEW 110V DUPLEX OUTLET AT 18" AFF UNLESS NOTED OTHERWISE
- ⊙-E NEW DEDICATED 110V DUPLEX OUTLET AT 18" AFF UNLESS NOTED OTHERWISE
- ⊙-E NEW TELEPHONE / DATA ROUGH-IN
- ⊙-E DEDICATED CIRCUITS FOR MODULAR. THE BASIS OF DEDICATED CIRCUIT PER 3 WORKSTATIONS. WIRING SHALL CONNECTION SHOULD BE A 3 CIRCUIT 8 WIRE CONNECTION.
- ⊙-E 110V DUPLEX OUTLET AND DATA ROUGH-IN KI 84" AFF CENTERED AROUND OUTLET.