

ARCHITECTURE
INTERIORS
PLANNING

6323 SPRING VALLEY ROAD
SUITE 200
DALLAS, TEXAS 75254
972.788.1945
972.788.2309 FAX
TGSArchitects.com

QUEST
DIAGNOSTICS


DENTON,
TEXAS

DATE ISSUED FOR
5/18/10 PERMIT


PROJECT 09049
SHEET P2
PART 5042

KEY NOTES:


- 1) UP TO 3"FD-G WITH TRAP PRIMER.
- 2) 2" SANITARY WASTE UP.
- 3) 3" SANITARY WASTE UP.
- 4) 4" SANITARY WASTE UP.
- 5) CONNECT TO EXISTING 4" SANITARY LINE. CONTRACTOR TO VERIFY THE EXACT LOCATION AND ELEVATION AT SITE.
- 6) 1-1/2" CW TO EXISTING SERVICE. CONTRACTOR TO VERIFY THE EXACT SIZE AND LOCATION AT SITE. PROVIDE A SHUT OFF VALVE AND BACK FLOW PREVENTER WITH UNION AT THE POINT OF CONNECTION.
- 7) 2" SANITARY WASTE DOWN, 2" VENT UP.
- 8) 3" SANITARY WASTE DOWN, 2" VENT UP.
- 9) 4" SANITARY WASTE DOWN, 2" VENT UP.
- 10) 3"FD-G WITH TRAP PRIMER.
- 11) 1/2" CW LINE DOWN IN WALL TO SERVE S-1. PROVIDE 1/2"x3/8"x3/8" THREE WAY STOP ON CW SUPPLY. ROUTE 3/8" CW LINE TO SINK AND 3/8" CW LINE TO EWH-1. ROUTE 3/8" HW LINE FROM EWH-1 TO SERVE SINK.
- 12) 1/2" CW LINE DOWN IN WALL TO SERVE L-1.
- 13) 1/2" CW LINE DOWN IN WALL TO SERVE L-1. PROVIDE 1/2"x3/8"x3/8" THREE WAY STOP ON CW SUPPLY. ROUTE 3/8" CW LINE TO LAV AND 3/8" CW LINE TO EWH-1. ROUTE 3/8" HW LINE FROM EWH-1 TO SERVE TWO LAV.
- 14) 1" CW LINE DOWN IN WALL TO SERVE WC-1.
- 15) 1/2" CW LINE DOWN IN WALL TO SERVE IM-1.
- 16) EXISTING 4" VENT RISER. CONTRACTOR TO VERIFY THE EXACT LOCATION AT SITE.

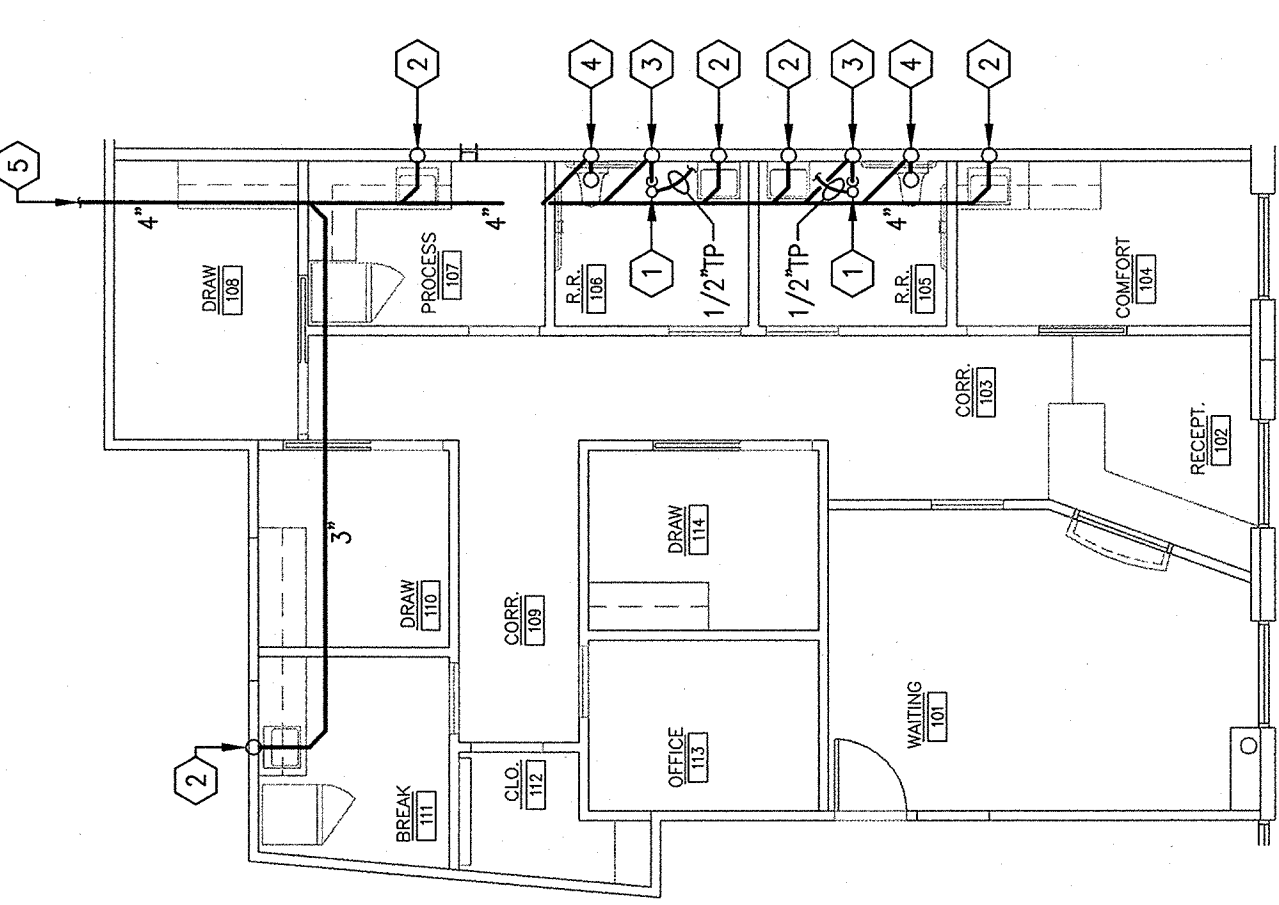

01 UNDERFLOOR PLAN - PLUMBING
SCALE: 1/8" = 1'-0"

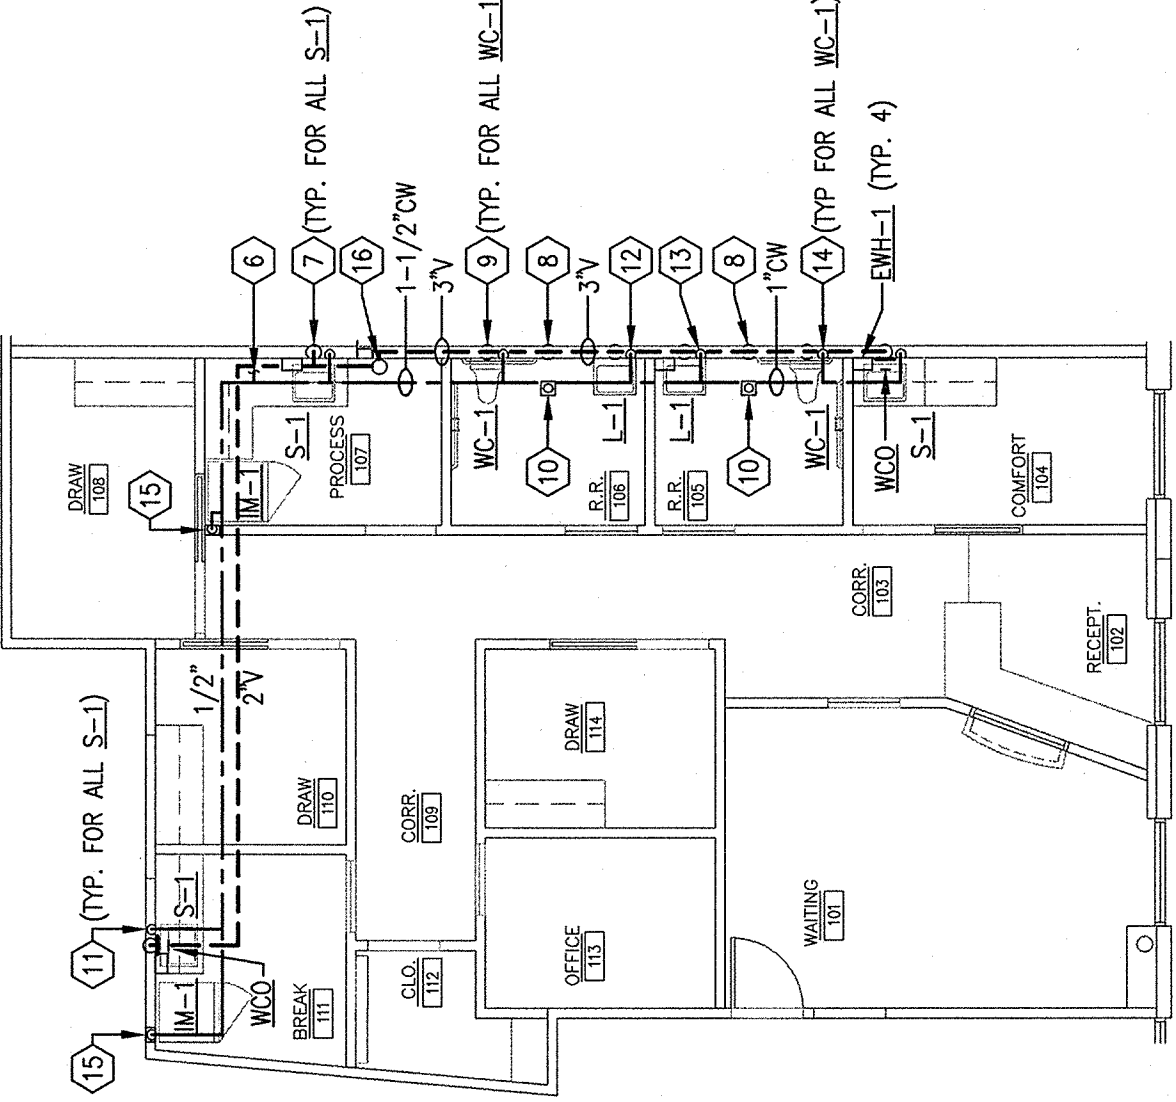

02 FLOOR PLAN - PLUMBING
SCALE: 1/8" = 1'-0"

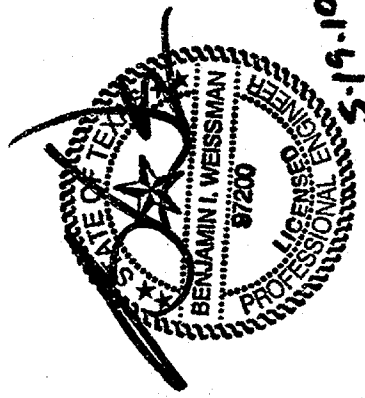

JSE Jordan & Skala Engineers
14260 Anthony Road, Suite 330
Dallas, TX 75244-5135
V: (469) 241-1615
F: (469) 241-1616
Project Number - 100-0192 Texas Firm Registration # F-4990
Drawn By: Checked By: